

From: "BNC Planning Correspondence" <da.corro@bncplanning.com.au>
Sent: Tue, 28 Jul 2026 14:34:22 +1000
To: "Development Assessment" <developmentassessment@townsville.qld.gov.au>
Cc: "Jayne Carter" <jayne.carter@townsville.qld.gov.au>; "Jack Coward" <jack.coward@townsville.qld.gov.au>; "Jake Kidner" <jake.kidner@townsville.qld.gov.au>
Subject: RE: MCU26/0048 - Letter - Information Request - 3 Gelling Crescent, Douglas QLD 4814
Attachments: DA056-26-IR-Response_1.0.pdf, 26-8309-OHC REV D.pdf

Please find attached correspondence relating to the above referenced development application.

Kind Regards,

Office 7 / Ground Floor / 41 Denham Street TOWNSVILLE CITY QLD 4810
PO BOX 5493 TOWNSVILLE QLD 4810 T. (07) 4724 1763 E. da.corro@bncplanning.com.au



©2026 This email is intended for the identified addressee only. The contents of this email may be confidential and subject to copyright. Unauthorised access, disclosure, use, forwarding or copying is strictly prohibited and may be unlawful. If you have received this email in error, please notify the sender by return email immediately and then delete it.

From: Jake Kidner <jake.kidner@townsville.qld.gov.au>
Sent: Monday, 22 June 2026 4:35 PM
To: BNC Planning Correspondence <da.corro@bncplanning.com.au>; Sai Sontoso-Miller - BNC Planning <:ssm@bncplanning.com.au>
Cc: Jayne Carter <jayne.carter@townsville.qld.gov.au>; Jack Coward <jack.coward@townsville.qld.gov.au>; Development Assessment <developmentassessment@townsville.qld.gov.au>
Subject: MCU26/0048 - Letter - Information Request - 3 Gelling Crescent, Douglas QLD 4814

Your Reference: DA056-26

Good afternoon,

Please find attached an electronic copy of the above mentioned.

As discussed over the phone, this application has been reallocated to Jayne Carter. Please direct any further correspondence to Jayne.

If you would like to follow the progress of your application online, please click on [Launch ePlanning](#) to access.

If you have any questions, please let me know.

Kind Regards,

Jake Kidner

A/ Coordinator Development Compliance - Planning and Development
Planning, Environment and Lifestyle

P 13 48 10 M 07 4417 5240 E jake.kidner@townsville.qld.gov.au

143 Walker Street, Townsville QLD 4810 | PO Box 1268, Townsville QLD 4810



OUR VISION - A globally connected community driven by lifestyle and nature **OUR PURPOSE** - Grow Townsville

Townsville City Council acknowledges the Wulgurukaba of Gurambilbarra and Yunbenun, Bindal, Gugu Badhun and Nywaigi as the Traditional Owners of this land. We pay our respects to their cultures, their ancestors and their Elders, past, present, and all future generations.



PRIVACY AND CONFIDENTIALITY NOTICE >> The information contained in this email is intended for the named recipients only. It may contain privileged and confidential information and if you are not the named intended recipient, you must not copy, distribute or take any action in reliance on it. If you have received this email in error, please notify us immediately by email or the telephone number or email listed above. *** *Please consider the environment before printing this email* ***



BNC Ref. DA056-26
Council Ref. MCU26/0048 (Assessment No. 4823008)

Date >> 28 July 2026

ASSESSMENT MANAGER
TOWNSVILLE CITY COUNCIL
PO BOX 1268
TOWNSVILLE QLD 4810
Via: Email

RE: APPLICANT RESPONSE TO ASSESSMENT MANAGER INFORMATION REQUEST – MATERIAL CHANGE OF USE DEVELOPMENT APPLICATION AT 3 GELLING CRESCENT, DOUGLAS QLD 4814

BNC Planning acting on behalf of the applicant, S. K. Mathew and E. Jacob, submits this response to the information request issued by Townsville City Council as assessment manager (dated 22 June 2026, Ref. MCU26/0048, Assessment No. 4823008), in accordance with section 13 of the Development Assessment Rules. The application seeks a development permit for a Material Change of Use for a Multiple Dwelling (three (3) dwelling units) at 3 Gelling Crescent, Douglas QLD 4814, Lot 61 on RP737887.

The applicant has responded by providing all of the information requested. A detailed response to each item of the information request is provided below.

ASSESSMENT MANAGER – TOWNSVILLE CITY COUNCIL – INFORMATION REQUEST

Request Item 1 – Amended plans

The applicant is requested to provide amended plans that detail the provision of private open space to each proposed unit.

Applicant's response

Amended plans (Site Layout Plan, Project No. 26-8309-OHC, Revision D, prepared by Nth Qld Construction Consulting Pty Ltd) are enclosed as Attachment A, identifying dedicated private open space for each of the two proposed new dwelling units (Unit 2 and Unit 3), delineated on the ground by new privacy fencing.

Unit 2 (ground floor): a fenced private open space area is provided directly adjoining the unit at ground level, with direct access from the dwelling and clear of the carport and driveway. The applicant confirms this area will be dimensioned on the final construction plans to demonstrate compliance with the minimum area (35m²) and minimum dimension (3m) requirements of AO29.1, and that it is located clear of site services and utilities.

BNC Planning Pty Ltd
ABN 80 147 498 397
Office 7 / Ground Floor / 41 Denham Street
TOWNSVILLE CITY QLD 4810
PO BOX 5493 TOWNSVILLE Q 4810
(07) 4724 1763 or 0438 789 612
enquire@bncplanning.com.au
www.bncplanning.com.au

Unit 3 (first floor): private open space is provided as a dedicated, exclusively allocated ground floor courtyard adjoining the base of the external stair access, rather than as an elevated balcony under AO29.2. The applicant submits that a balcony of the minimum area required by AO29.2 (16m², given Unit 3 is a two-bedroom unit) is not a practical outcome for this site, as a balcony of that size would either reduce the internal floor area of the unit below a reasonable functional standard, or cantilever toward the side boundary and the adjoining unit in a manner inconsistent with the setback and amenity outcomes sought elsewhere in the code.

The applicant submits that the dedicated ground floor courtyard achieves the intent of PO29 – being private open space that is well-proportioned, appealing, functional and easily accessible, provides a high level of privacy for residents and neighbours, and is of sufficient size and shape to meet the needs of a diversity of potential residents – to a standard that meets or exceeds what a compliant balcony would provide. A ground level courtyard is also considered more appropriate to Townsville's climate, providing shaded, landscaped outdoor living space in preference to an exposed, elevated balcony. Privacy is reinforced by the new fencing shown on the amended plans, which physically separates the Unit 3 courtyard from the Unit 2 space and driveway.

The applicant acknowledges Council's advice that AO29.2 contemplates a balcony for units located above ground level, and requests that this alternative, performance-based approach to PO29 be accepted on its merits. The applicant welcomes Council's feedback on this aspect prior to a decision being made on the application.

Request Item 2 – Location of clothes drying facilities

The applicant is requested to identify the location of clothes drying facilities for each unit.

Applicant's response

Amended plans (Site Layout Plan, Project No. 26-8309-OHC, Revision D, Attachment A) identify a dedicated clothes line within each of the private open space areas for Unit 2 and Unit 3, located adjacent to each unit's fenced courtyard.

As the clothes drying facilities for both units are provided within ground level private open space areas rather than on a balcony, the 10% balcony area limitation under AO29.3 does not directly apply to either unit. The applicant submits that the identified clothes line locations are of a scale and position consistent with the amenity outcomes sought by the Low density residential zone code, and do not compromise the functionality or privacy of the balance of either private open space area.

Request Item 3 – Further justification regarding building over services

The applicant is requested to demonstrate how the proposed new building complies with the relevant provisions of QDC MP 1.4 – Building over or near relevant infrastructure with respect to its proposed siting over the existing sewer line.

Applicant's response

The applicant has given detailed consideration to QDC MP 1.4 – Building over or near relevant infrastructure (MP 1.4), Part 9.3.6 Works code and Planning Scheme Policy SC6.4.14 Public Utilities, in light of Council's advice that the proposed new building (Units 2 and 3) is sited over the existing sewer line and property connection.

Response to Council's options hierarchy

Option 1 (relocating the proposed structure elsewhere on the property) is not considered reasonably achievable. The site is a compact 692m² corner allotment with dual frontage to Gelling Crescent and Benton Court. The site layout retains the existing dwelling (Unit 1) and accommodates the new building (Units 2 and 3) within the balance of the developable envelope, at side boundary setbacks of 1.5m that already reflect the minimum standard under AO23.3 of the Low density residential zone code, and provides the six on-site car parking spaces required under Parking rates planning scheme policy SC6.10. There is no alternative footprint within the site that avoids the sewer alignment without breaching a boundary setback, reducing required car parking below the minimum rate, or increasing site cover beyond the 65% maximum under AO22.

Option 2 (re-aligning the sewer within the site via an operational works application) is also not considered the most appropriate outcome available. Given the compact and low-lying nature of the site, part of which is affected by the Flood hazard overlay along the Benton Court frontage, the length and fall available across the site to accommodate a re-aligned gravity main at Council's minimum required grade is limited. The applicant submits this is likely to enliven the very basis on which Council's Option 3 threshold applies.

On this basis, the applicant proposes to proceed on Option 3, being the removal of the existing 1983 sewer main and its replacement with a new main following the current alignment, via a future operational works application to allow detailed engineering assessment and design. This approach directly addresses the P1(c) risk identified above by ensuring the serviceable life of the sewer asset will generally match the life of the new residential building, is consistent with the age profile of the existing asset, and avoids the grade and lifecycle-cost difficulties associated with Option 2.

Option 4 is not available in this instance. Council's advice confirms this option applies only where the existing sewer assets have already been replaced with new assets within the proposed building location. The existing main is the original 1983 asset and has not been previously replaced, and Option 4 is therefore not enlivened, irrespective of the outcome of any CCTV condition assessment.

Property connection and easement matters

The applicant notes Council's advice that construction over the existing property connection is not supported. The precise location of the property connection relative to the new building footprint will be confirmed and addressed as part of the detailed design for the proposed sewer main replacement, to ensure the new building does not encroach over the connection.

On the basis of the above, the applicant requests that this response be accepted as adequately addressing Request Item 3, on the basis that: (a) a building development application incorporating an alternative solution for P1 and P2 of MP 1.4, certified by a suitably qualified RPEQ, will be submitted and referred to Council as the relevant service provider; and (b) an operational works application for the removal and replacement of the existing sewer main (Option 3) will be lodged to allow detailed engineering design and assessment, prior to any building work being carried out over the new main.

Summary

The applicant trusts the information provided in this response addresses each matter raised in the information request and provides sufficient basis for Council to continue its assessment of the development application. Please do not hesitate to contact the undersigned should any further information be required.



Kind regards,

Benjamin Collings, Director
BNC Planning Pty Ltd

Attachments:
Attachment A – Amended Site Layout Plan

ORANGE HEALTH CARE EXTENSION TO RESIDENCE

3 GELLING CRESCENT,
DOUGLAS QLD 4814

PROJECT NO. - 26-8309-OHC
REVISION NO. - D

NTH QLD CONSTRUCTION CONSULTING PTY LTD
P.O Box 21 AITKENVALE Q 4814
Unit 1, 9 Civil Rd, GARBUTT Q 4814
Ph 4728 2339 - Fax 4728 2966
Mobile Ph 0429 001 726
Email - bswitzer@nqcc.biz



DRAWING LIST	
SHEET NO.	SHEET NAME
1	COVER
2	3D VIEW 1
3	3D VIEW 2
4	3D VIEW 3
5	3D VIEW 4
6	3D VIEW 5
7	3D VIEW 6
8	3D VIEW 7
9	3D VIEW 8
10	SITE LAYOUT PLAN
11	GROUND FLOOR SLAB LAYOUT PLAN
12	GROUND FLOOR BLOCKWORK LAYOUT PLAN
13	FIRST FLOOR BLOCKWORK LAYOUT PLAN
14	EXISTING GROUND FLOOR LAYOUT PLAN
15	PROPOSED GROUND FLOOR LAYOUT PLAN
16	PROPOSED FIRST FLOOR LAYOUT PLAN
17	FRONT & SIDE ELEVATIONS
17A	GROUND FLOOR PARTITION LAYOUT PLAN
18	REAR & SIDE ELEVATIONS
19A	FIRST FLOOR PARTITION LAYOUT PLAN
20A	FIRST FLOOR SLAB LAYOUT PLAN
21	ROOF FRAMING LAYOUT PLAN
22	GROUND FLOOR ROOF SHEETING LAYOUT PLAN
23	STORMWATER DRAINAGE LAYOUT PLAN
24	GROUND FLOOR LIGHTING LAYOUT PLAN
25	FIRST FLOOR LIGHTING LAYOUT PLAN
26	GROUND FLOOR ELECTRICAL LAYOUT PLAN
27	FIRST FLOOR ELECTRICAL LAYOUT PLAN
28	GROUND FLOOR DRAINAGE LAYOUT PLAN
29	FIRST FLOOR DRAINAGE LAYOUT PLAN
30	SECTION A-A
31	SECTION B-B
32	STANDARD CONSTRUCTION DETAILS
33	ENERGY EFFICIENCY & OPENINGS SCHEDULE
34	GENERAL NOTES
35	WINDOW & DOOR SCHEDULE
36	STANDARD CONSTRUCTION DETAILS
37	STANDARD CONSTRUCTION DETAILS
38	AIR-CELL INSULATION DETAILS
39	STANDARD DEVELOPMENT NOTES
40	STANDARD SAFE DESIGN REPORT DETAILS
41	STANDARD SAFE DESIGN REPORT DETAILS
42	FIRST FLOOR ROOF SHEETING LAYOUT PLAN
43	SECTION C-C
44	SECTION D-D
45	SECTION E-E
46	INTERNAL ELEVATIONS - UNIT 2
47	INTERNAL ELEVATIONS - UNIT 3
48	SECTION A-A DETAIL



3D VIEW 1

PRELIMINARY DRAWING
NOT FOR CONSTRUCTION



NTH QLD CONSTRUCTION CONSULTING P. L.
P.O Box 21 AITKENVALE Q 4814
UNIT 1, 9 CIVIL RD, GARBUTT Q 4814
PH 4728 2339 - FAX 4728 2966
MOBILE PH 0429 001 726
EMAIL - bswitzer@nqcc.biz
ABN & GST - 16 111 343 161



building designers
association of
queensland inc.

COPYRIGHT ©

COPYRIGHT LAWS PROHIBIT
THE USE OF THIS DESIGN IN
ANY FORM WITHOUT
WRITTEN CONSENT FROM
NTH QLD CONSTRUCTION
CONSULTING PTY LTD

AMENDMENTS

DATE	REVISION	DESCRIPTION
18.02.26	A	FOR CLIENT DISCUSSION
24.03.26	B	DESIGN CHANGES FOR PLANNING
07.07.26	C	CONSTRUCTION ISSUE
15.07.26	D	SITE LAYOUT DETAILS ADDED AS PER COUNCIL REQUEST

VERIFY ALL DIMENSIONS ON
SITE BEFORE COMMENCING
ANY BUILDING WORKS.

LICENSED UNDER THE QLD
BUILDING SERVICES AUTHORITY
(QBSA Act 1991)
BUILDING DESIGN DRAFTING
RESIDENTIAL DESIGN DRAFTING
CONTRACTOR LICENCE
NUMBER - 1117428

CLIENT - ORANGE HEALTH CARE	
PROJECT - EXTENSION TO RESIDENCE	
LOCATION - 3 GELLING CRESCENT, DOUGLAS QLD 4814	
PROJECT NO. - 26-8309-OHC	REVISION D
DATE - FEBRUARY 2026	
DRAWN - GM	SCALE - AS SHOWN
CHECKED BY - B. J. SWITZER	SHEET NO. - 2 - A3



3D VIEW 2

PRELIMINARY DRAWING
NOT FOR CONSTRUCTION



NTH QLD CONSTRUCTION CONSULTING P. L.
P.O Box 21 AITKENVALE Q 4814
UNIT 1, 9 CIVIL RD, GARBUTT Q 4814
PH 4728 2339 - FAX 4728 2966
MOBILE PH 0429 001 726
EMAIL - bswitzer@nqcc.biz
ABN & GST - 16 111 343 161



COPYRIGHT ©

COPYRIGHT LAWS PROHIBIT
THE USE OF THIS DESIGN IN
ANY FORM WITHOUT
WRITTEN CONSENT FROM
NTH QLD CONSTRUCTION
CONSULTING PTY LTD

AMENDMENTS

DATE	REVISION	DESCRIPTION
18.02.26	A	FOR CLIENT DISCUSSION
24.03.26	B	DESIGN CHANGES FOR PLANNING
07.07.26	C	CONSTRUCTION ISSUE
15.07.26	D	SITE LAYOUT DETAILS ADDED AS PER COUNCIL REQUEST

VERIFY ALL DIMENSIONS ON
SITE BEFORE COMMENCING
ANY BUILDING WORKS.


LICENSED UNDER THE QLD
BUILDING SERVICES AUTHORITY
(QBSA Act 1991)
BUILDING DESIGN DRAFTING
RESIDENTIAL DESIGN DRAFTING
CONTRACTOR LICENCE
NUMBER - 1117428

CLIENT - ORANGE HEALTH CARE	
PROJECT - EXTENSION TO RESIDENCE	
LOCATION - 3 GELLING CRESCENT, DOUGLAS QLD 4814	
PROJECT NO. - 26-8309-OHC	REVISION D
DATE - FEBRUARY 2026	
DRAWN - GM	SCALE - AS SHOWN
CHECKED BY - B. J. SWITZER	SHEET NO. - 3 - A3



3D VIEW 3

PRELIMINARY DRAWING
NOT FOR CONSTRUCTION

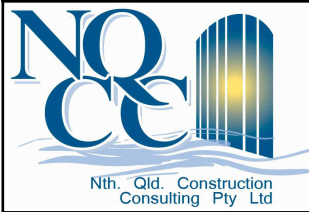

NTH QLD CONSTRUCTION CONSULTING P. L.
P.O Box 21 AITKENVALE Q 4814
UNIT 1, 9 CIVIL RD, GARBUTT Q 4814
PH 4728 2339 - FAX 4728 2966
MOBILE PH 0429 001 726
EMAIL - bswitzer@nqcc.biz
ABN & GST - 16 111 343 161



building designers
association of
queensland inc.

COPYRIGHT ©

COPYRIGHT LAWS PROHIBIT
THE USE OF THIS DESIGN IN
ANY FORM WITHOUT
WRITTEN CONSENT FROM
NTH QLD CONSTRUCTION
CONSULTING PTY LTD

AMENDMENTS

DATE	REVISION	DESCRIPTION
18.02.26	A	FOR CLIENT DISCUSSION
24.03.26	B	DESIGN CHANGES FOR PLANNING
07.07.26	C	CONSTRUCTION ISSUE
15.07.26	D	SITE LAYOUT DETAILS ADDED AS PER COUNCIL REQUEST

VERIFY ALL DIMENSIONS ON
SITE BEFORE COMMENCING
ANY BUILDING WORKS.


LICENSED UNDER THE QLD
BUILDING SERVICES AUTHORITY
(QBSA Act 1991)
BUILDING DESIGN DRAFTING
RESIDENTIAL DESIGN DRAFTING
CONTRACTOR LICENCE
NUMBER - 1117428

CLIENT - ORANGE HEALTH CARE	
PROJECT - EXTENSION TO RESIDENCE	
LOCATION - 3 GELLING CRESCENT, DOUGLAS QLD 4814	
PROJECT NO. - 26-8309-OHC	REVISION D
DATE - FEBRUARY 2026	
DRAWN - GM	SCALE - AS SHOWN
CHECKED BY - B. J. SWITZER	SHEET NO. - 4 - A3



3D VIEW 4

PRELIMINARY DRAWING
NOT FOR CONSTRUCTION

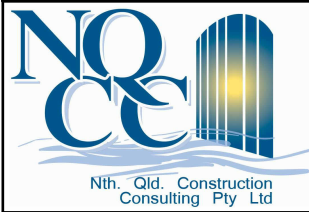

NTH QLD CONSTRUCTION CONSULTING P. L.
P.O Box 21 AITKENVALE Q 4814
UNIT 1, 9 CIVIL RD, GARBUTT Q 4814
PH 4728 2339 - FAX 4728 2966
MOBILE PH 0429 001 726
EMAIL - bswitzer@nqcc.biz
ABN & GST - 16 111 343 161



COPYRIGHT ©
COPYRIGHT LAWS PROHIBIT
THE USE OF THIS DESIGN IN
ANY FORM WITHOUT
WRITTEN CONSENT FROM
NTH QLD CONSTRUCTION
CONSULTING PTY LTD

AMENDMENTS		
DATE	REVISION	DESCRIPTION
18.02.26	A	FOR CLIENT DISCUSSION
24.03.26	B	DESIGN CHANGES FOR PLANNING
07.07.26	C	CONSTRUCTION ISSUE
15.07.26	D	SITE LAYOUT DETAILS ADDED AS PER COUNCIL REQUEST

VERIFY ALL DIMENSIONS ON
SITE BEFORE COMMENCING
ANY BUILDING WORKS.

LICENSED UNDER THE QLD
BUILDING SERVICES AUTHORITY
(QBSA Act 1991)
BUILDING DESIGN DRAFTING
RESIDENTIAL DESIGN DRAFTING
CONTRACTOR LICENCE
NUMBER - 1117428

CLIENT - ORANGE HEALTH CARE	
PROJECT - EXTENSION TO RESIDENCE	
LOCATION - 3 GELLING CRESCENT, DOUGLAS QLD 4814	
PROJECT NO. - 26-8309-OHC	REVISION D
DATE - FEBRUARY 2026	
DRAWN - GM	SCALE - AS SHOWN
CHECKED BY - B. J. SWITZER	SHEET NO. - 5 - A3



3D VIEW 5

PRELIMINARY DRAWING
NOT FOR CONSTRUCTION



NTH QLD CONSTRUCTION CONSULTING P. L.
P.O Box 21 AITKENVALE Q 4814
UNIT 1, 9 CIVIL RD, GARBUTT Q 4814
PH 4728 2339 - FAX 4728 2966
MOBILE PH 0429 001 726
EMAIL - bswitzer@nqcc.biz
ABN & GST - 16 111 343 161



building designers
association of
queensland inc.

COPYRIGHT ©

COPYRIGHT LAWS PROHIBIT
THE USE OF THIS DESIGN IN
ANY FORM WITHOUT
WRITTEN CONSENT FROM
NTH QLD CONSTRUCTION
CONSULTING PTY LTD

AMENDMENTS

DATE	REVISION	DESCRIPTION
18.02.26	A	FOR CLIENT DISCUSSION
24.03.26	B	DESIGN CHANGES FOR PLANNING
07.07.26	C	CONSTRUCTION ISSUE
15.07.26	D	SITE LAYOUT DETAILS ADDED AS PER COUNCIL REQUEST

VERIFY ALL DIMENSIONS ON
SITE BEFORE COMMENCING
ANY BUILDING WORKS.


LICENSED UNDER THE QLD
BUILDING SERVICES AUTHORITY
(QBSA Act 1991)
BUILDING DESIGN DRAFTING
RESIDENTIAL DESIGN DRAFTING
CONTRACTOR LICENCE
NUMBER - 1117428

CLIENT - ORANGE HEALTH CARE	
PROJECT - EXTENSION TO RESIDENCE	
LOCATION - 3 GELLING CRESCENT, DOUGLAS QLD 4814	
PROJECT NO. - 26-8309-OHC	REVISION D
DATE - FEBRUARY 2026	
DRAWN - GM	SCALE - AS SHOWN
CHECKED BY - B. J. SWITZER	SHEET NO. - 6 - A3



3D VIEW 6

PRELIMINARY DRAWING
NOT FOR CONSTRUCTION

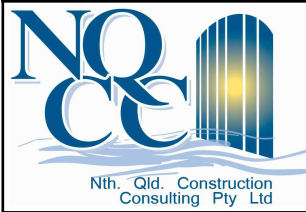

NTH QLD CONSTRUCTION CONSULTING P. L.
P.O Box 21 AITKENVALE Q 4814
UNIT 1, 9 CIVIL RD, GARBUTT Q 4814
PH 4728 2339 - FAX 4728 2966
MOBILE PH 0429 001 726
EMAIL - bswitzer@nqcc.biz
ABN & GST - 16 111 343 161



building designers
association of
queensland inc.

COPYRIGHT ©

COPYRIGHT LAWS PROHIBIT
THE USE OF THIS DESIGN IN
ANY FORM WITHOUT
WRITTEN CONSENT FROM
NTH QLD CONSTRUCTION
CONSULTING PTY LTD

AMENDMENTS

DATE	REVISION	DESCRIPTION
18.02.26	A	FOR CLIENT DISCUSSION
24.03.26	B	DESIGN CHANGES FOR PLANNING
07.07.26	C	CONSTRUCTION ISSUE
15.07.26	D	SITE LAYOUT DETAILS ADDED AS PER COUNCIL REQUEST

VERIFY ALL DIMENSIONS ON
SITE BEFORE COMMENCING
ANY BUILDING WORKS.


LICENSED UNDER THE QLD
BUILDING SERVICES AUTHORITY
(QBSA Act 1991)
BUILDING DESIGN DRAFTING
RESIDENTIAL DESIGN DRAFTING
CONTRACTOR LICENCE
NUMBER - 1117428

CLIENT - ORANGE HEALTH CARE	
PROJECT - EXTENSION TO RESIDENCE	
LOCATION - 3 GELLING CRESCENT, DOUGLAS QLD 4814	
PROJECT NO. - 26-8309-OHC	REVISION D
DATE - FEBRUARY 2026	
DRAWN - GM	SCALE - AS SHOWN
CHECKED BY - B. J. SWITZER	SHEET NO. - 7 - A3



3D VIEW 7

PRELIMINARY DRAWING
NOT FOR CONSTRUCTION

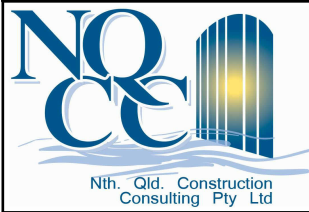

NTH QLD CONSTRUCTION CONSULTING P. L.
P.O Box 21 AITKENVALE Q 4814
UNIT 1, 9 CIVIL RD, GARbutt Q 4814
PH 4728 2339 - FAX 4728 2966
MOBILE PH 0429 001 726
EMAIL - bswitzer@nqcc.biz
ABN & GST - 16 111 343 161



building designers
association of
queensland inc.

COPYRIGHT ©

COPYRIGHT LAWS PROHIBIT
THE USE OF THIS DESIGN IN
ANY FORM WITHOUT
WRITTEN CONSENT FROM
NTH QLD CONSTRUCTION
CONSULTING PTY LTD

AMENDMENTS

DATE	REVISION	DESCRIPTION
18.02.26	A	FOR CLIENT DISCUSSION
24.03.26	B	DESIGN CHANGES FOR PLANNING
07.07.26	C	CONSTRUCTION ISSUE
15.07.26	D	SITE LAYOUT DETAILS ADDED AS PER COUNCIL REQUEST

VERIFY ALL DIMENSIONS ON
SITE BEFORE COMMENCING
ANY BUILDING WORKS.

LICENSED UNDER THE QLD
BUILDING SERVICES AUTHORITY
(QBSA Act 1991)
BUILDING DESIGN DRAFTING
RESIDENTIAL DESIGN DRAFTING
CONTRACTOR LICENCE
NUMBER - 1117428

CLIENT - ORANGE HEALTH CARE	
PROJECT - EXTENSION TO RESIDENCE	
LOCATION - 3 GELLING CRESCENT, DOUGLAS QLD 4814	
PROJECT NO. - 26-8309-OHC	REVISION D
DATE - FEBRUARY 2026	
DRAWN - GM	SCALE - AS SHOWN
CHECKED BY - B. J. SWITZER	SHEET NO. - 8 - A3



3D VIEW 8

PRELIMINARY DRAWING
NOT FOR CONSTRUCTION



NTH QLD CONSTRUCTION CONSULTING P. L.
P.O Box 21 AITKENVALE Q 4814
UNIT 1, 9 CIVIL RD, GARBUTT Q 4814
PH 4728 2339 - FAX 4728 2966
MOBILE PH 0429 001 726
EMAIL - bswitzer@nqcc.biz
ABN & GST - 16 111 343 161



building designers
association of
queensland inc.

COPYRIGHT ©

COPYRIGHT LAWS PROHIBIT
THE USE OF THIS DESIGN IN
ANY FORM WITHOUT
WRITTEN CONSENT FROM
NTH QLD CONSTRUCTION
CONSULTING PTY LTD


AMENDMENTS

DATE	REVISION	DESCRIPTION
18.02.26	A	FOR CLIENT DISCUSSION
24.03.26	B	DESIGN CHANGES FOR PLANNING
07.07.26	C	CONSTRUCTION ISSUE
15.07.26	D	SITE LAYOUT DETAILS ADDED AS PER COUNCIL REQUEST

VERIFY ALL DIMENSIONS ON
SITE BEFORE COMMENCING
ANY BUILDING WORKS.


LICENSED UNDER THE QLD
BUILDING SERVICES AUTHORITY
(QBSA Act 1991)
BUILDING DESIGN DRAFTING
RESIDENTIAL DESIGN DRAFTING
CONTRACTOR LICENCE
NUMBER - 1117428

CLIENT - ORANGE HEALTH CARE	
PROJECT - EXTENSION TO RESIDENCE	
LOCATION - 3 GELLING CRESCENT, DOUGLAS QLD 4814	
PROJECT NO. - 26-8309-OHC	REVISION D
DATE - FEBRUARY 2026	
DRAWN - GM	SCALE - AS SHOWN
CHECKED BY - B. J. SWITZER	SHEET NO. - 9 - A3

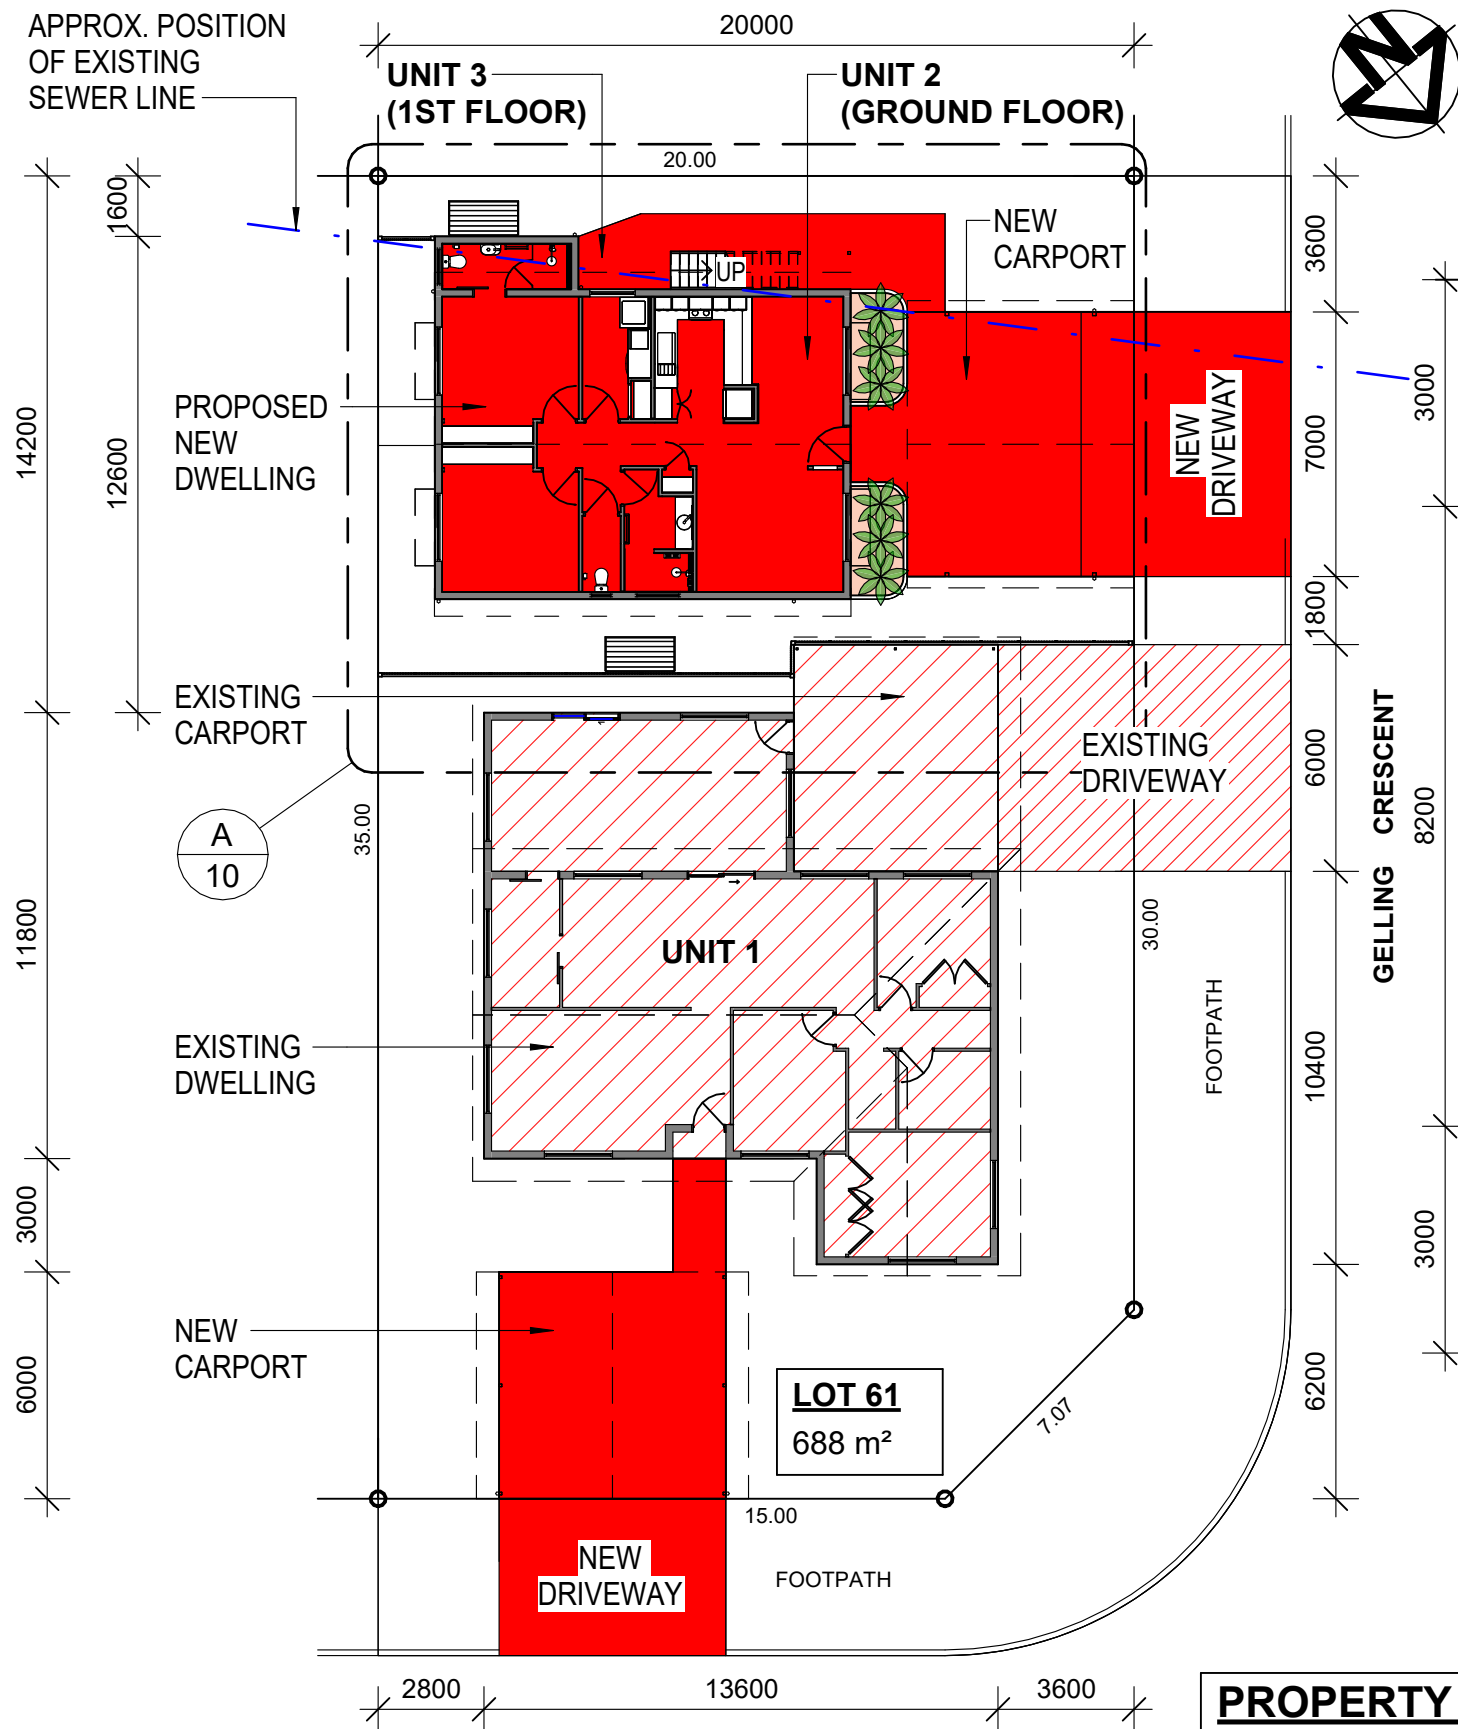

SITE LAYOUT PLAN
SCALE: 1 : 200

PROPERTY DESCRIPTION
LOT 61 ON RP737887
AREA OF LAND - 688 m²

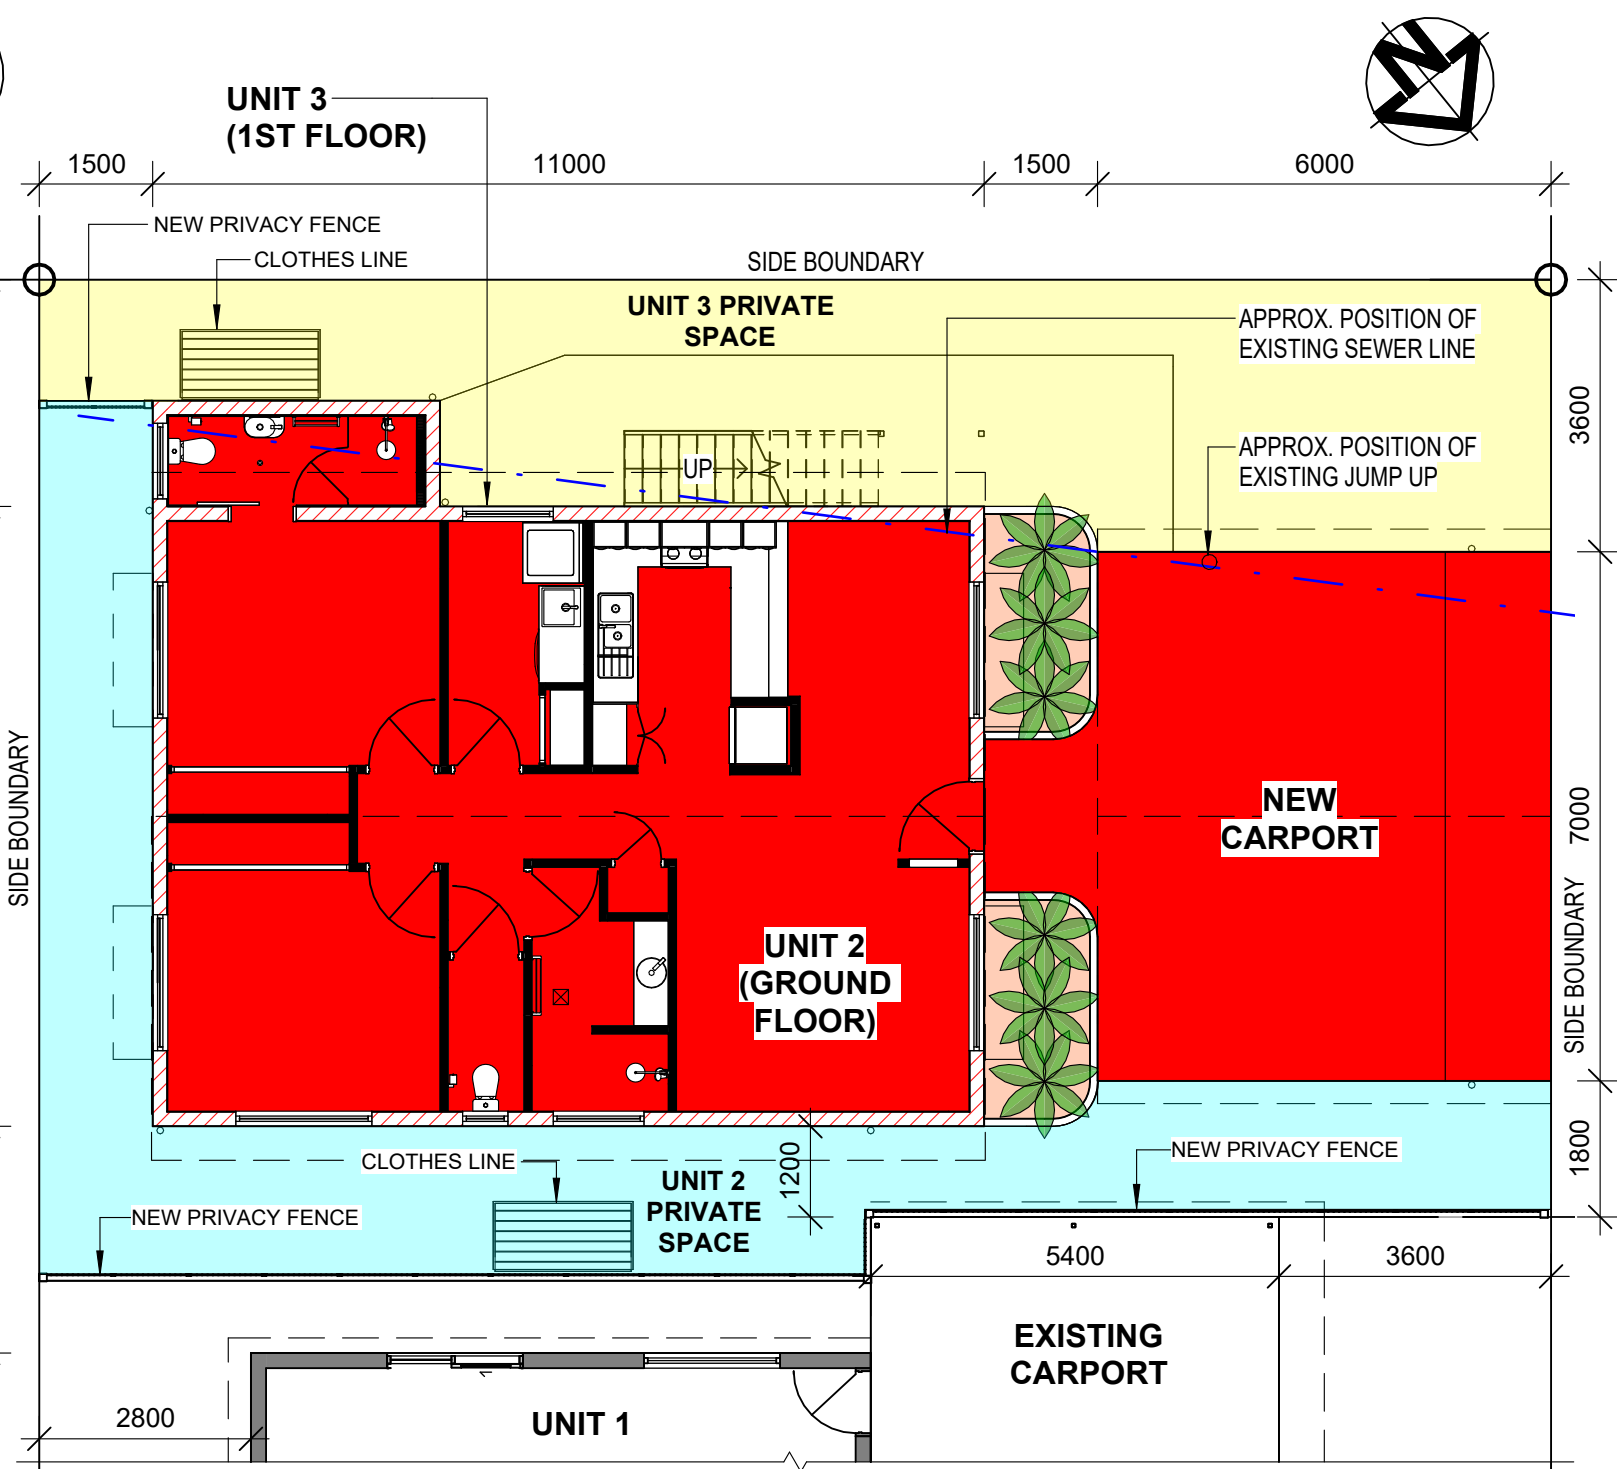

DETAIL

Scale: 1 : 100

A

10

SITE COVERAGE	
BUILDINGS	SITE COVER
EXISTING HOUSE	21.98%
EXISTING PATIO	4.71%
NEW CARPORT/PATH	12.41%
NEW DWELLING	13.88%
Grand total	52.99%

**PRELIMINARY DRAWING
NOT FOR CONSTRUCTION**



NTH QLD CONSTRUCTION CONSULTING P. L.
P.O Box 21 AITKENVALE Q 4814
UNIT 1, 9 CIVIL RD, GARbutt Q 4814
PH 4728 2339 - FAX 4728 2966
MOBILE PH 0429 001 726
EMAIL - bswitzer@nqcc.biz
ABN & GST - 16 111 343 161




COPYRIGHT ©
COPYRIGHT LAWS PROHIBIT
THE USE OF THIS DESIGN IN
ANY FORM WITHOUT
WRITTEN CONSENT FROM
NTH QLD CONSTRUCTION
CONSULTING PTY LTD

AMENDMENTS		
DATE	REVISION	DESCRIPTION
18.02.26	A	FOR CLIENT DISCUSSION
24.03.26	B	DESIGN CHANGES FOR PLANNING
07.07.26	C	CONSTRUCTION ISSUE
15.07.26	D	SITE LAYOUT DETAILS ADDED AS PER COUNCIL REQUEST

VERIFY ALL DIMENSIONS ON
SITE BEFORE COMMENCING
ANY BUILDING WORKS.

LICENSED UNDER THE QLD
BUILDING SERVICES AUTHORITY
(QBSA Act 1991)
BUILDING DESIGN DRAFTING
RESIDENTIAL DESIGN DRAFTING
CONTRACTOR LICENCE
NUMBER - 1117428


CLIENT - ORANGE HEALTH CARE	
PROJECT - EXTENSION TO RESIDENCE	
LOCATION - 3 GELLING CRESCENT, DOUGLAS QLD 4814	
PROJECT NO. - 26-8309-OHC	REVISION D
DATE - FEBRUARY 2026	
DRAWN - GM	SCALE - AS SHOWN
CHECKED BY - B. J. SWITZER	SHEET NO. - 10 - A3

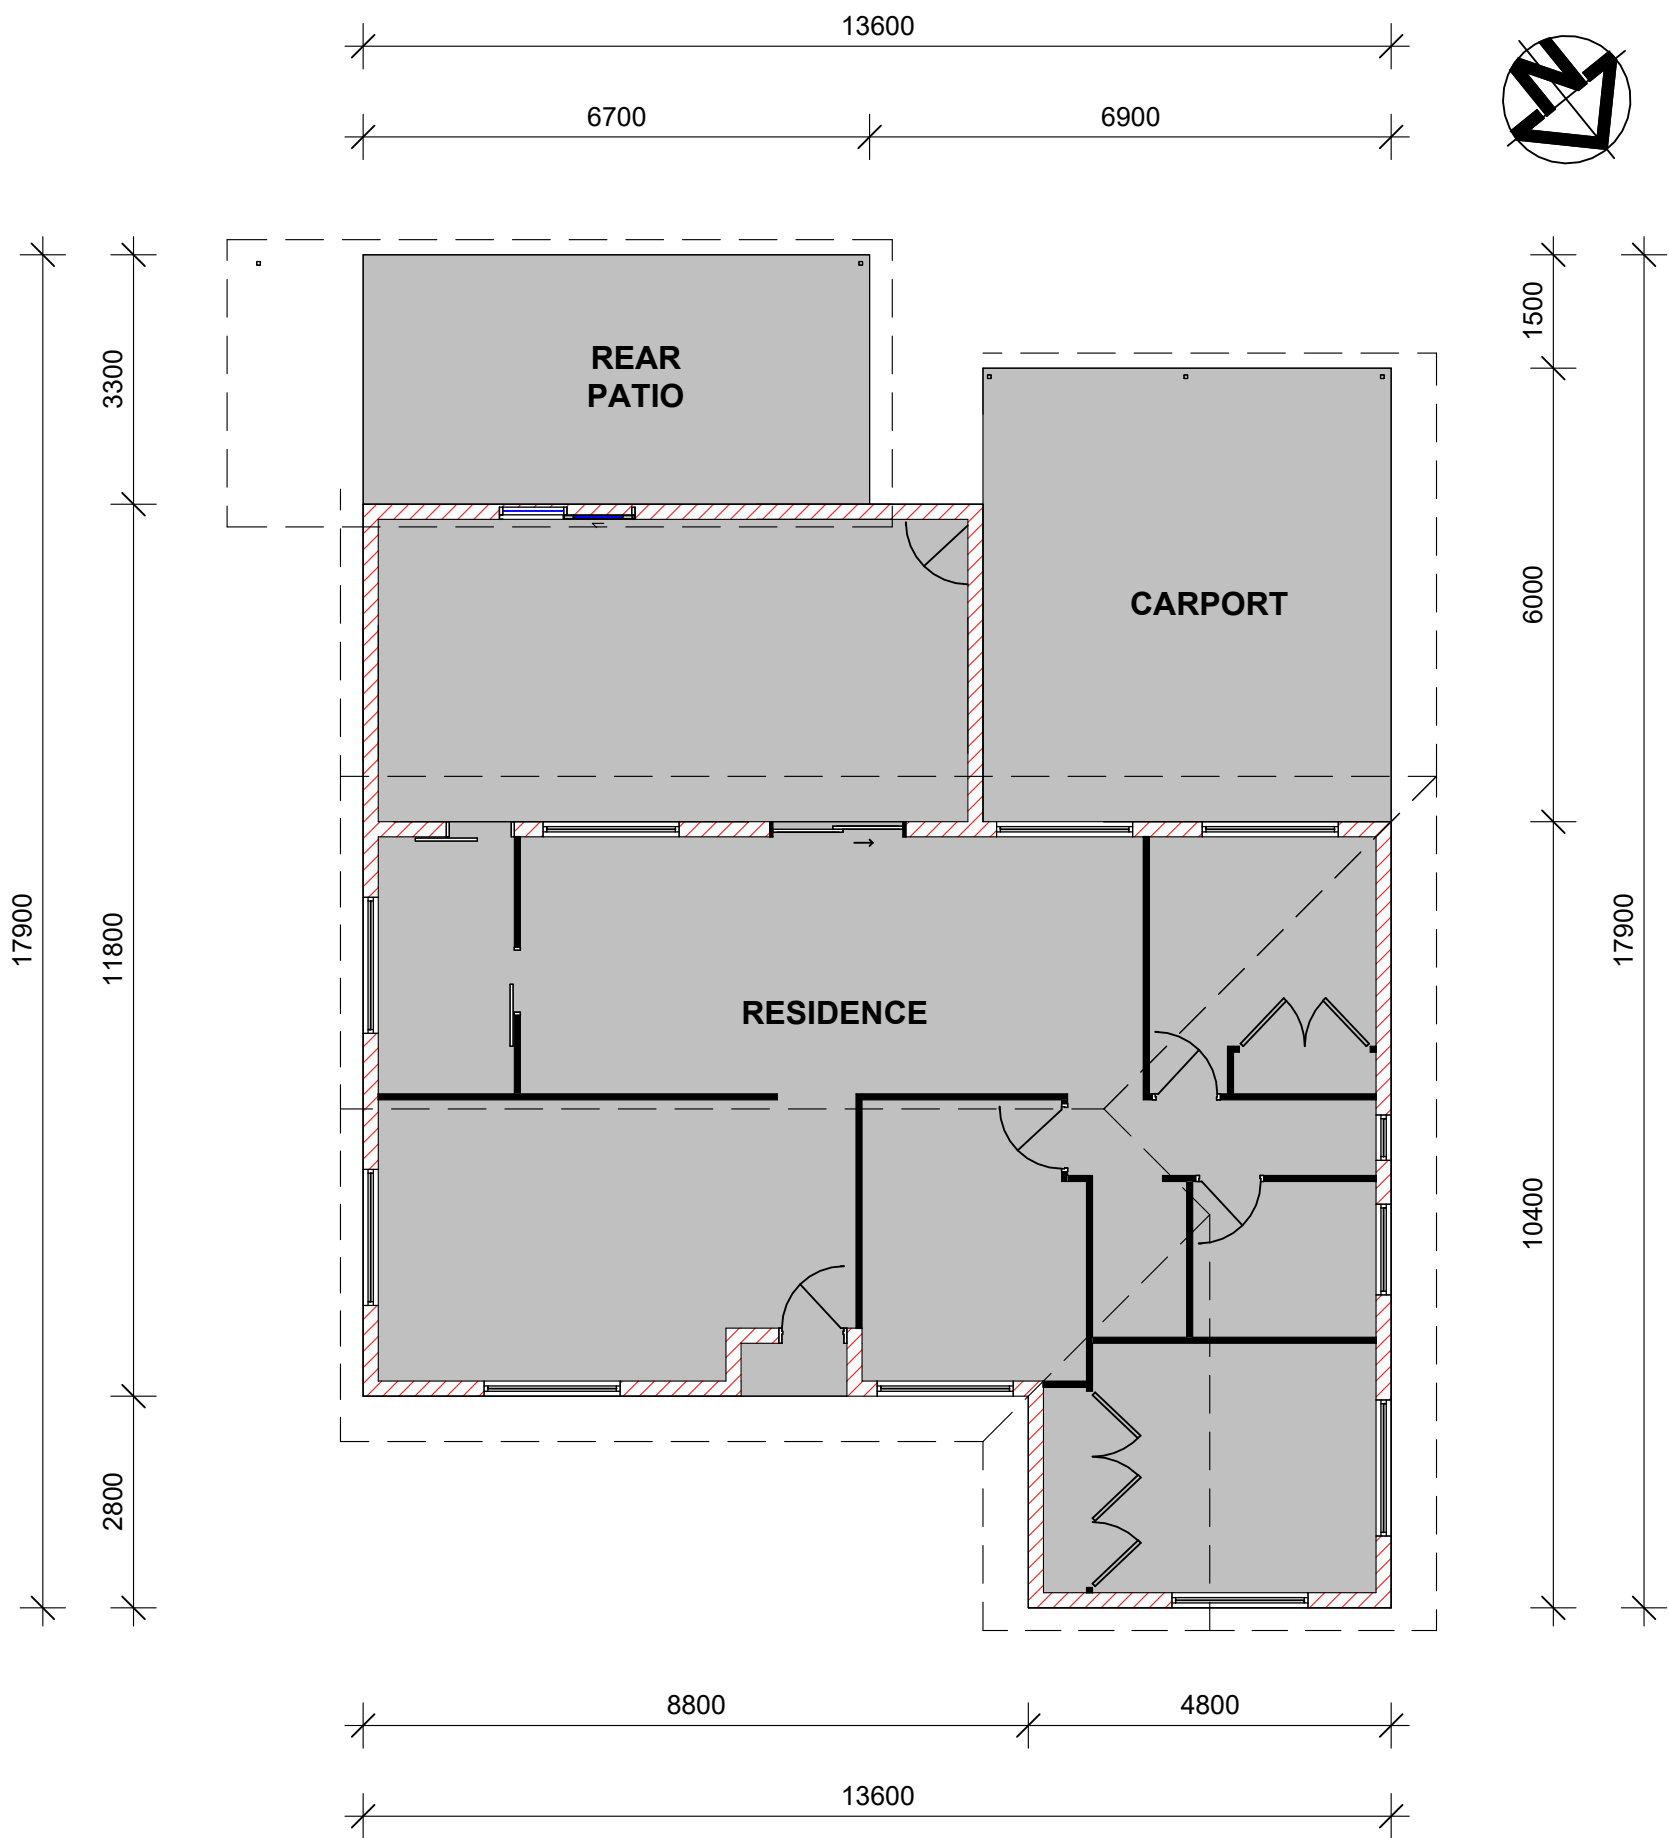

EXISTING GROUND FLOOR LAYOUT PLAN
SCALE: 1 : 100

PRELIMINARY DRAWING
NOT FOR CONSTRUCTION

BUILDER		
AMENDMENTS		
DATE	REVISION	DESCRIPTION
18.02.26	A	FOR CLIENT DISCUSSION
24.03.26	B	DESIGN CHANGES FOR PLANNING
07.07.26	C	CONSTRUCTION ISSUE
15.07.26	D	SITE LAYOUT DETAILS ADDED AS PER COUNCIL REQUEST
NTH QLD CONSTRUCTION CONSULTING P. L. P.O Box 21 AITKENVALE Q 4814 UNIT 1, 9 CIVIL RD, GARBUTT Q 4814 PH 4728 2339 - FAX 4728 2966 MOBILE PH 0429 001 726 EMAIL - bswitzer@nqcc.biz ABN & GST - 16 111 343 161		
		
COPYRIGHT ©		
COPYRIGHT LAWS PROHIBIT THE USE OF THIS DESIGN IN ANY FORM WITHOUT WRITTEN CONSENT FROM NTH QLD CONSTRUCTION CONSULTING PTY LTD		
		
LICENSED UNDER THE QUEENSLAND BUILDING SERVICES AUTHORITY(QBSA Act 1991) BUILDING DESIGN DRAFTING RESIDENTIAL DESIGN DRAFTING CONTRACTOR LICENCE NUMBER - 1117428		
VERIFY ALL DIMENSION ON SITE BEFORE COMMENCING ANY BUILDING WORKS.		
CLIENT ORANGE HEALTH CARE		
PROJECT EXTENSION TO RESIDENCE		
LOCATION 3 GELLING CRESCENT, DOUGLAS QLD 4814		
DATE FEBRUARY 2026		
PROJECT NO. 26-8309-OHC	REVISION D	
SCALE AS SHOWN	DRAWN GM	
CHECKED BY B. J. SWITZER	SHEET NO. 14 - A3	

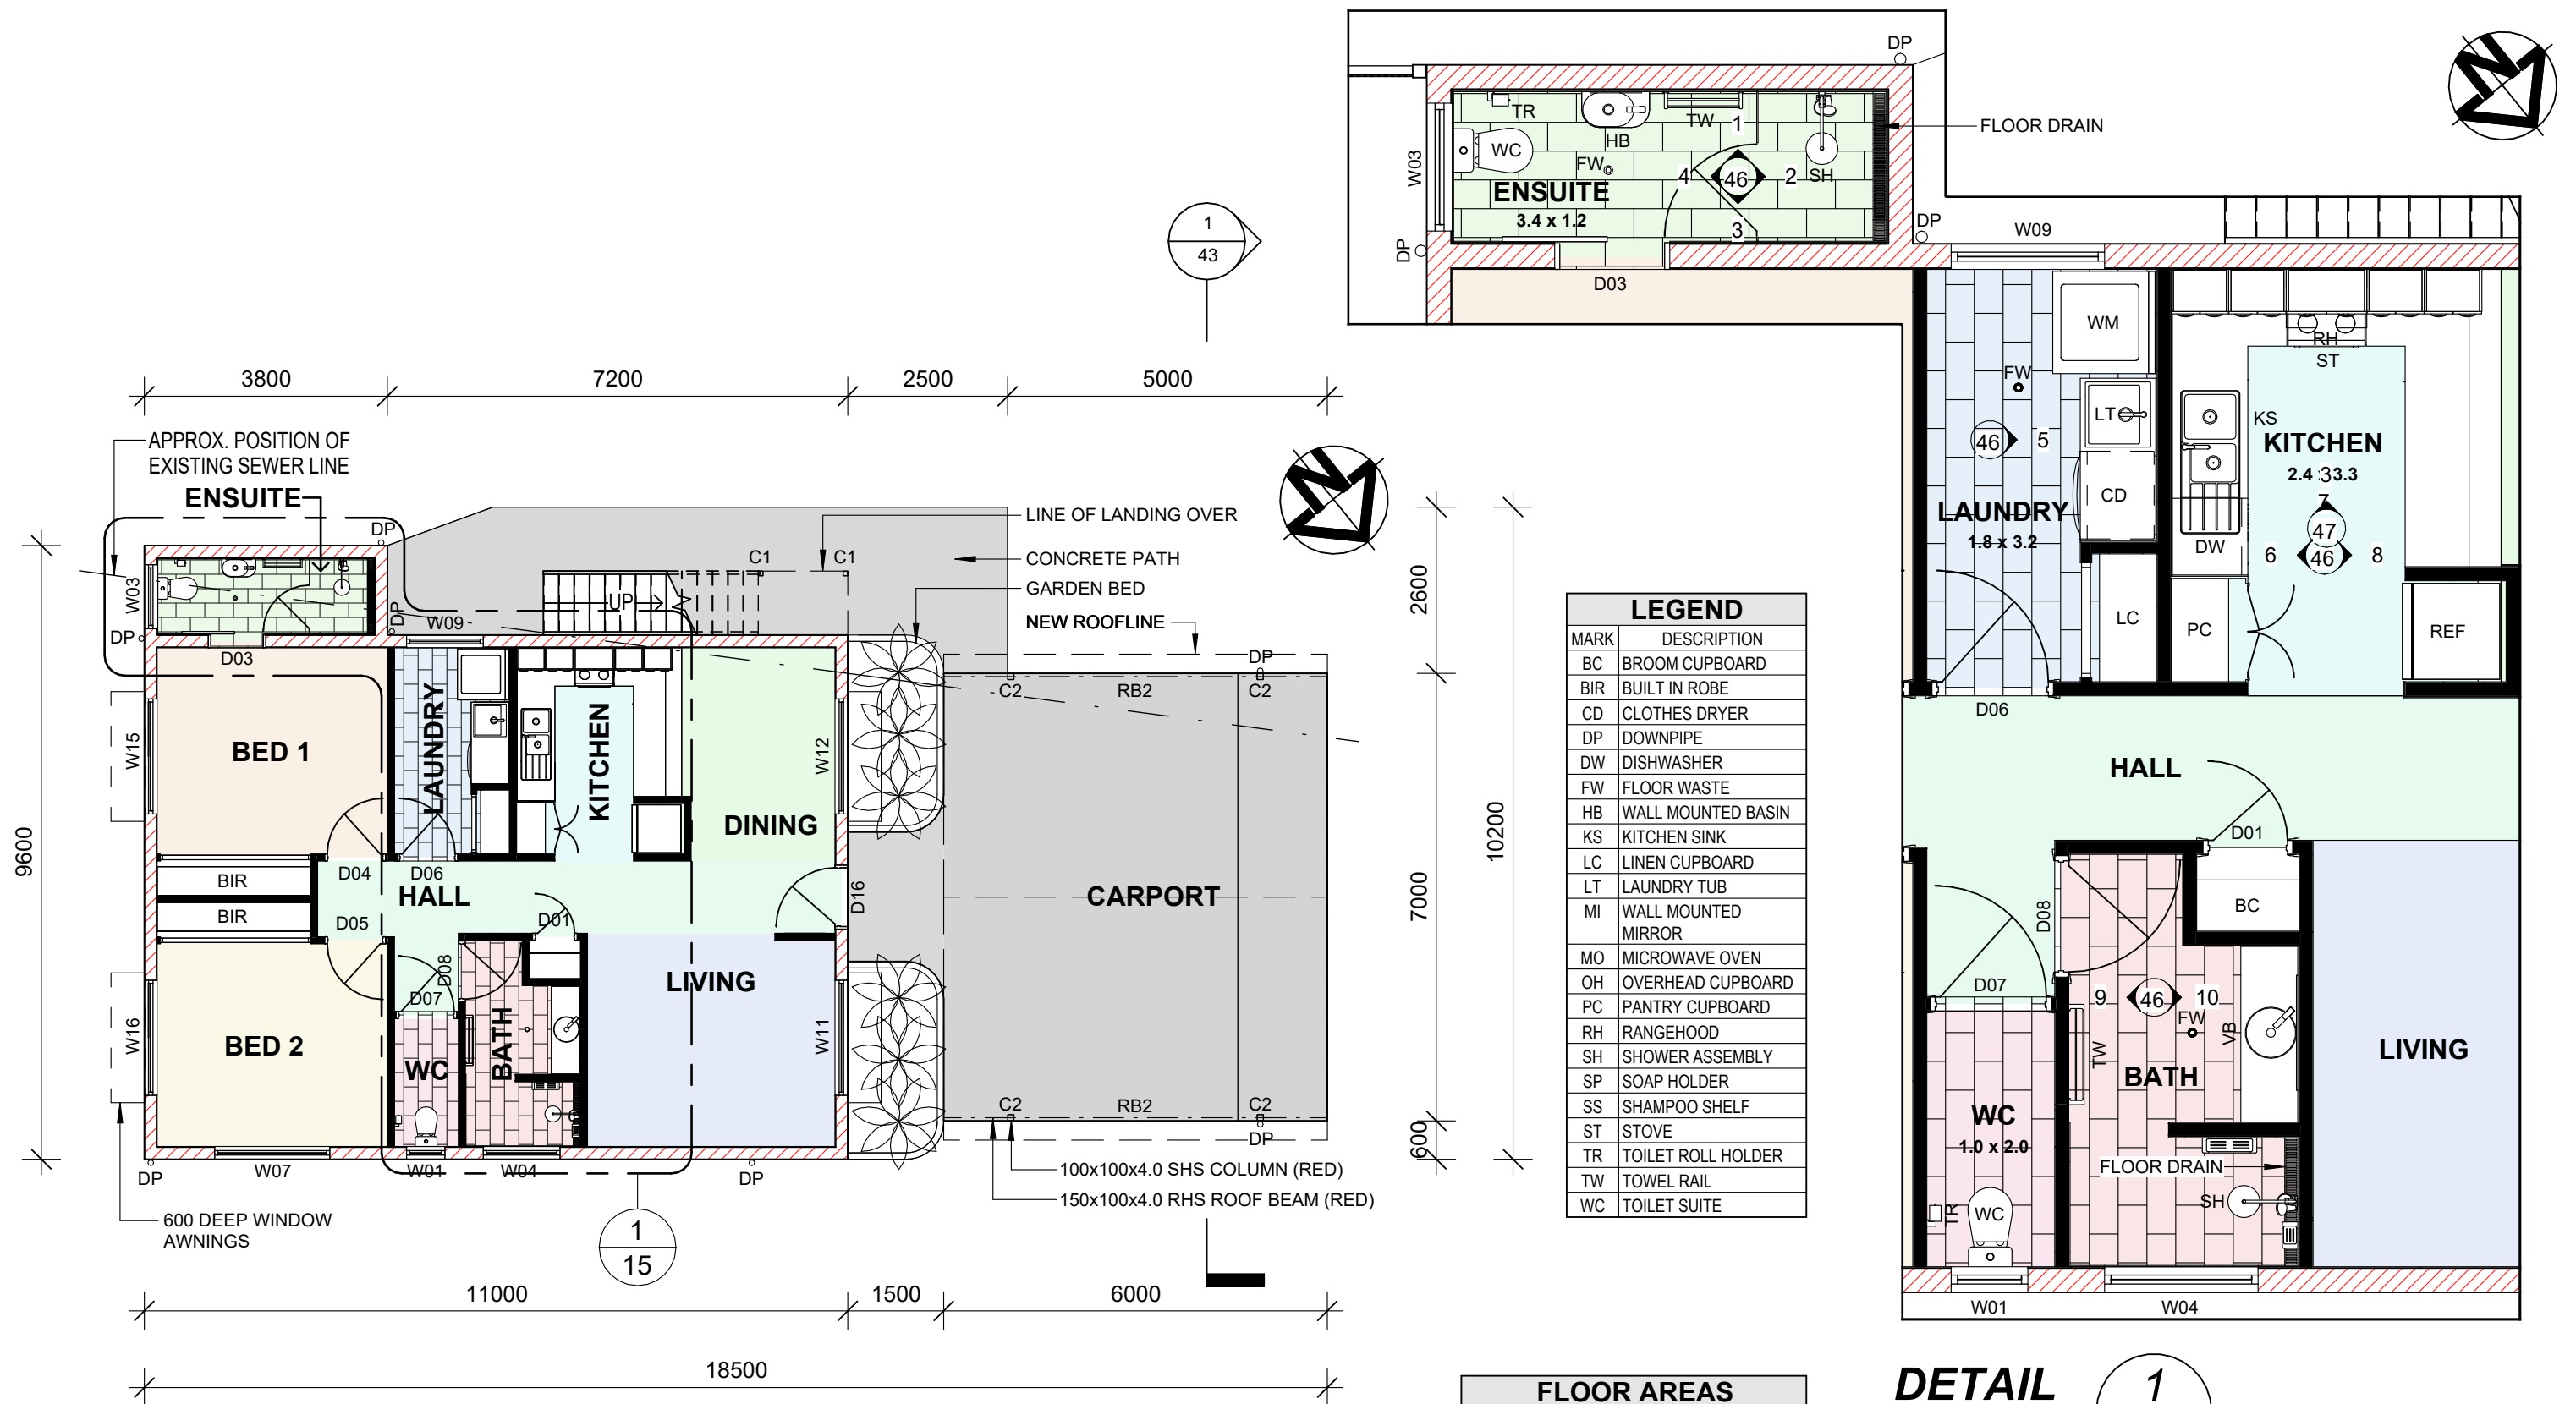

PROPOSED GROUND FLOOR LAYOUT PLAN - UNIT 2

SCALE: 1 : 100

REFER SHEET 28 FOR DOOR
& WINDOW SCHEDULE

(RED) - REFER
ENGINEERS DRAWINGS

DETAIL 1

Scale: 1 : 50

PRELIMINARY DRAWING
NOT FOR CONSTRUCTION



NTH QLD CONSTRUCTION CONSULTING P. L.
P.O Box 21 AITKENVALE Q 4814
UNIT 1, 9 CIVIL RD, GARbutt Q 4814
PH 4728 2339 - FAX 4728 2966
MOBILE PH 0429 001 726
EMAIL - bswitzer@nqcc.biz
ABN & GST - 16 111 343 161



COPYRIGHT ©

COPYRIGHT LAWS PROHIBIT
THE USE OF THIS DESIGN IN
ANY FORM WITHOUT
WRITTEN CONSENT FROM
NTH QLD CONSTRUCTION
CONSULTING PTY LTD


AMENDMENTS

DATE	REVISION	DESCRIPTION
18.02.26	A	FOR CLIENT DISCUSSION
24.03.26	B	DESIGN CHANGES FOR PLANNING
07.07.26	C	CONSTRUCTION ISSUE
15.07.26	D	SITE LAYOUT DETAILS ADDED AS PER COUNCIL REQUEST

VERIFY ALL DIMENSIONS ON
SITE BEFORE COMMENCING
ANY BUILDING WORKS.

LICENSED UNDER THE QLD
BUILDING SERVICES AUTHORITY
(QBSA Act 1991)
BUILDING DESIGN DRAFTING
RESIDENTIAL DESIGN DRAFTING
CONTRACTOR LICENCE
NUMBER - 1117428

CLIENT - ORANGE HEALTH CARE	
PROJECT - EXTENSION TO RESIDENCE	
LOCATION - 3 GELLING CRESCENT, DOUGLAS QLD 4814	
PROJECT NO. - 26-8309-OHC	REVISION D
DATE - FEBRUARY 2026	
DRAWN - GM	SCALE - AS SHOWN
CHECKED BY - B. J. SWITZER	SHEET NO. - 15 - A3

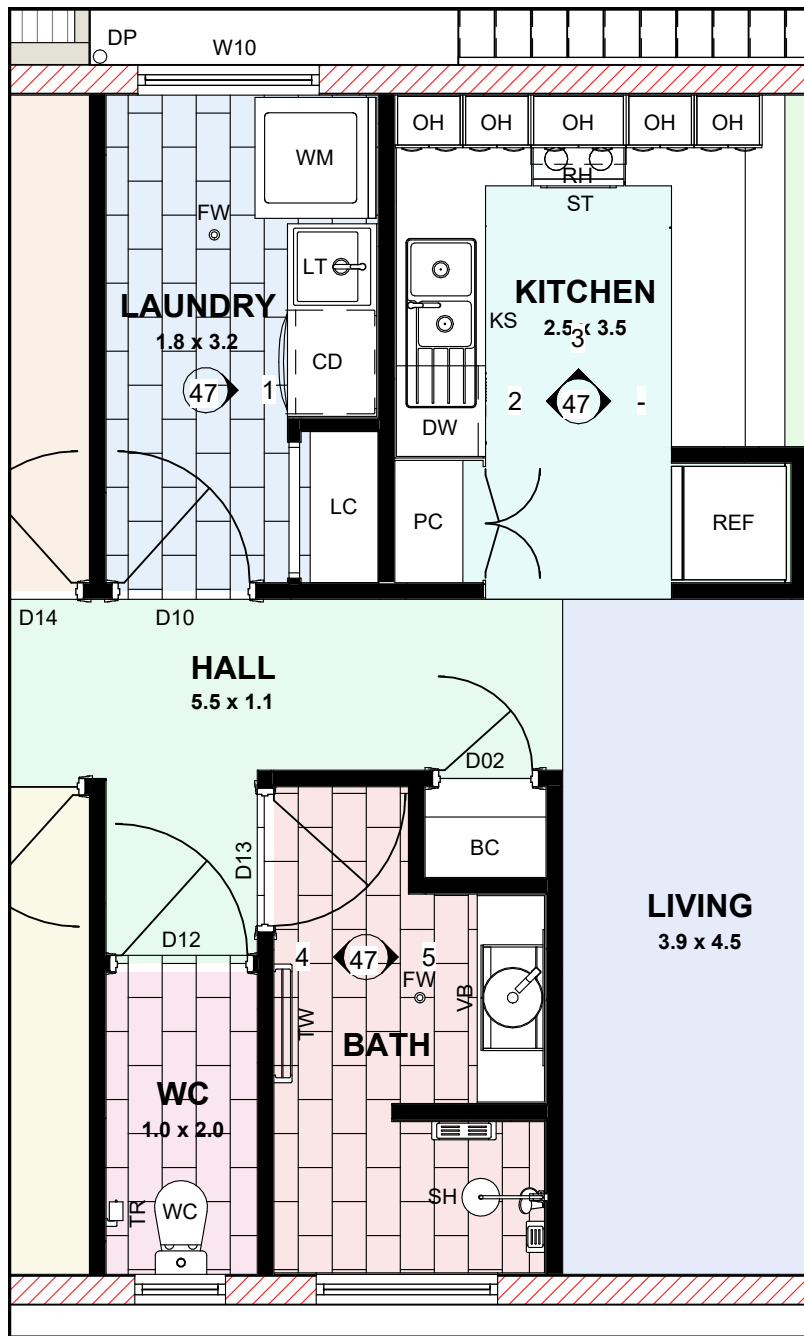


DETAIL

1

Scale: 1 : 50

16

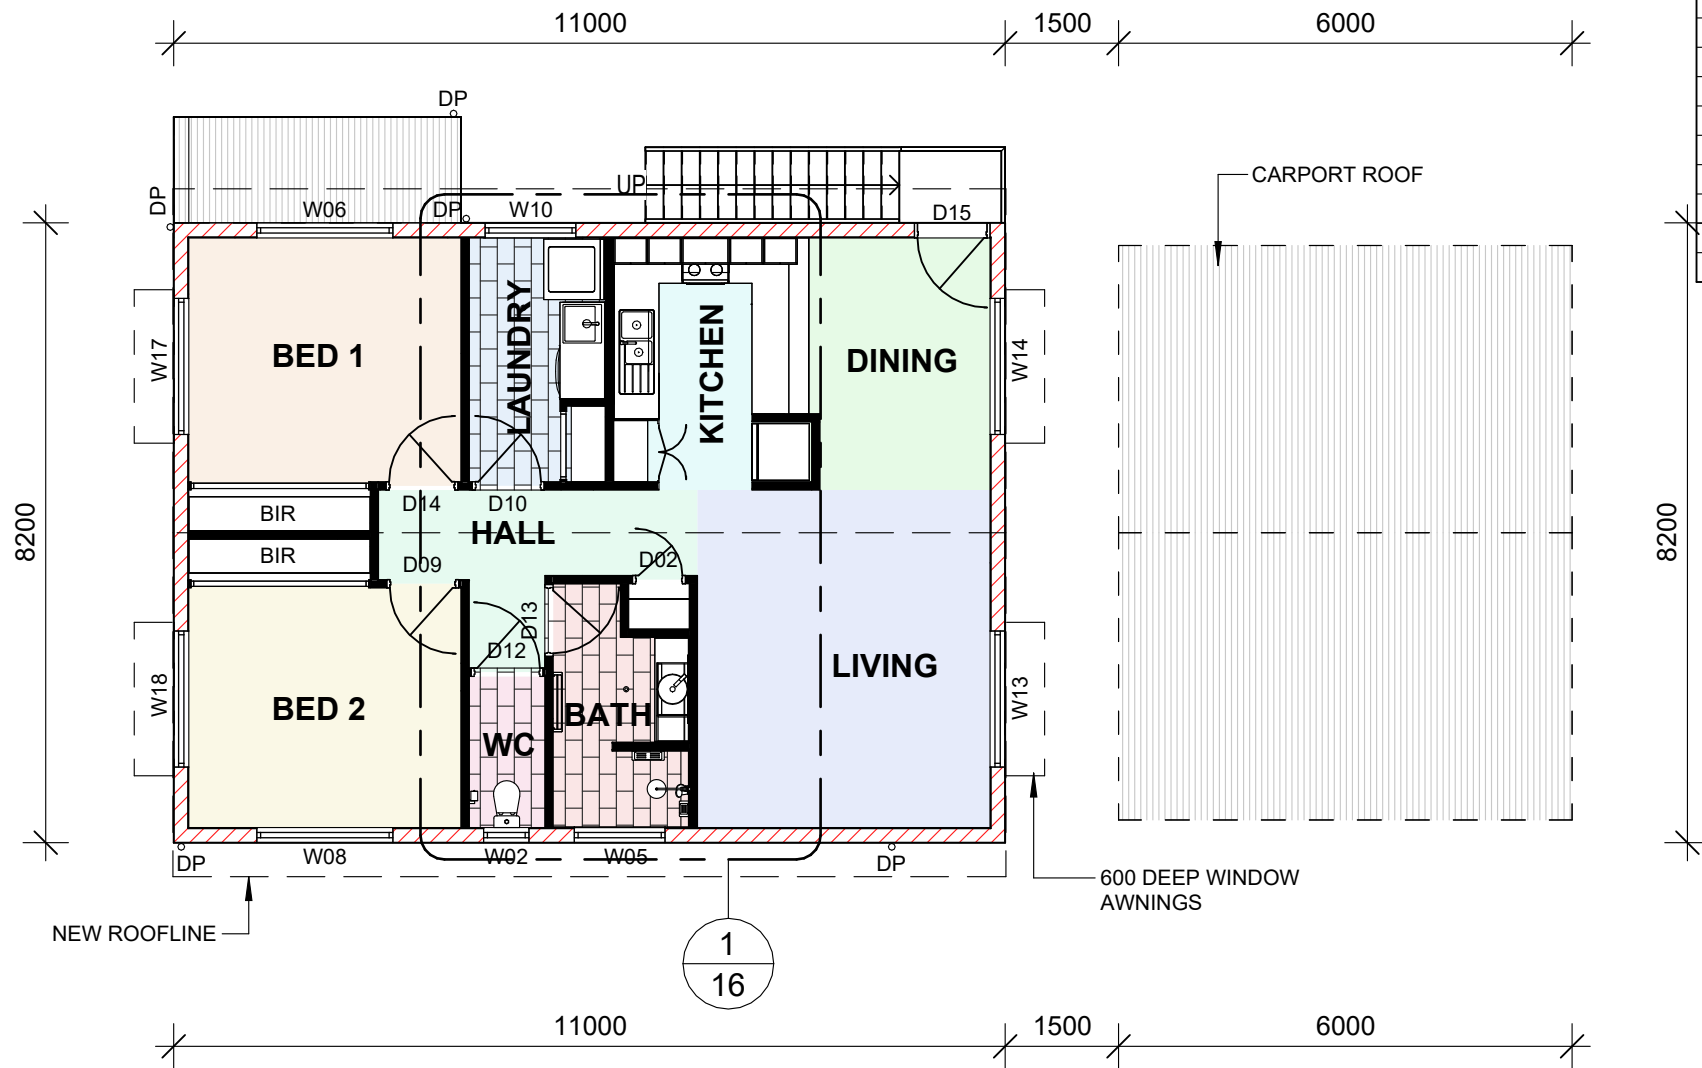

PROPOSED FIRST FLOOR LAYOUT PLAN - UNIT 3

SCALE: 1 : 100

REFER SHEET 28 FOR DOOR
& WINDOW SCHEDULE

(RED) - REFER
ENGINEERS DRAWINGS

FLOOR AREAS	
DESCRIPTION	AREA
NEW CARPORT/PATH	105.03 m ²
NEW FIRST FLOOR UNIT	96.89 m ²
NEW GROUND FLOOR UNIT	95.52 m ²
Grand total	297.44 m ²

LEGEND	
MARK	DESCRIPTION
BC	BROOM CUPBOARD
BIR	BUILT IN ROBE
CD	CLOTHES DRYER
DP	DOWNPIPE
DW	DISHWASHER
FW	FLOOR WASTE
HB	WALL MOUNTED BASIN
KS	KITCHEN SINK
LC	LINEN CUPBOARD
LT	LAUNDRY TUB
MI	WALL MOUNTED MIRROR
MO	MICROWAVE OVEN
OH	OVERHEAD CUPBOARD
PC	PANTRY CUPBOARD
RH	RANGEHOOD
SH	SHOWER ASSEMBLY
SP	SOAP HOLDER
SS	SHAMPOO SHELF
ST	STOVE
TR	TOILET ROLL HOLDER
TW	TOWEL RAIL
WC	TOILET SUITE

PRELIMINARY DRAWING
NOT FOR CONSTRUCTION



NTH QLD CONSTRUCTION CONSULTING P. L.
P.O Box 21 AITKENVALE Q 4814
UNIT 1, 9 CIVIL RD, GARbutt Q 4814
PH 4728 2339 - FAX 4728 2966
MOBILE PH 0429 001 726
EMAIL - bswitzer@nqcc.biz
ABN & GST - 16 111 343 161



COPYRIGHT ©


COPYRIGHT LAWS PROHIBIT
THE USE OF THIS DESIGN IN
ANY FORM WITHOUT
WRITTEN CONSENT FROM
NTH QLD CONSTRUCTION
CONSULTING PTY LTD

AMENDMENTS		
DATE	REVISION	DESCRIPTION
18.02.26	A	FOR CLIENT DISCUSSION
24.03.26	B	DESIGN CHANGES FOR PLANNING
07.07.26	C	CONSTRUCTION ISSUE
15.07.26	D	SITE LAYOUT DETAILS ADDED AS PER COUNCIL REQUEST


VERIFY ALL DIMENSIONS ON
SITE BEFORE COMMENCING
ANY BUILDING WORKS.

LICENSED UNDER THE QLD
BUILDING SERVICES AUTHORITY
(QBSA Act 1991)
BUILDING DESIGN DRAFTING
RESIDENTIAL DESIGN DRAFTING
CONTRACTOR LICENCE
NUMBER - 1117428

CLIENT - ORANGE HEALTH CARE	
PROJECT - EXTENSION TO RESIDENCE	
LOCATION - 3 GELLING CRESCENT, DOUGLAS QLD 4814	
PROJECT NO. - 26-8309-OHC	REVISION D
DATE - FEBRUARY 2026	
DRAWN - GM	SCALE - AS SHOWN
CHECKED BY - B. J. SWITZER	SHEET NO. - 16 - A3

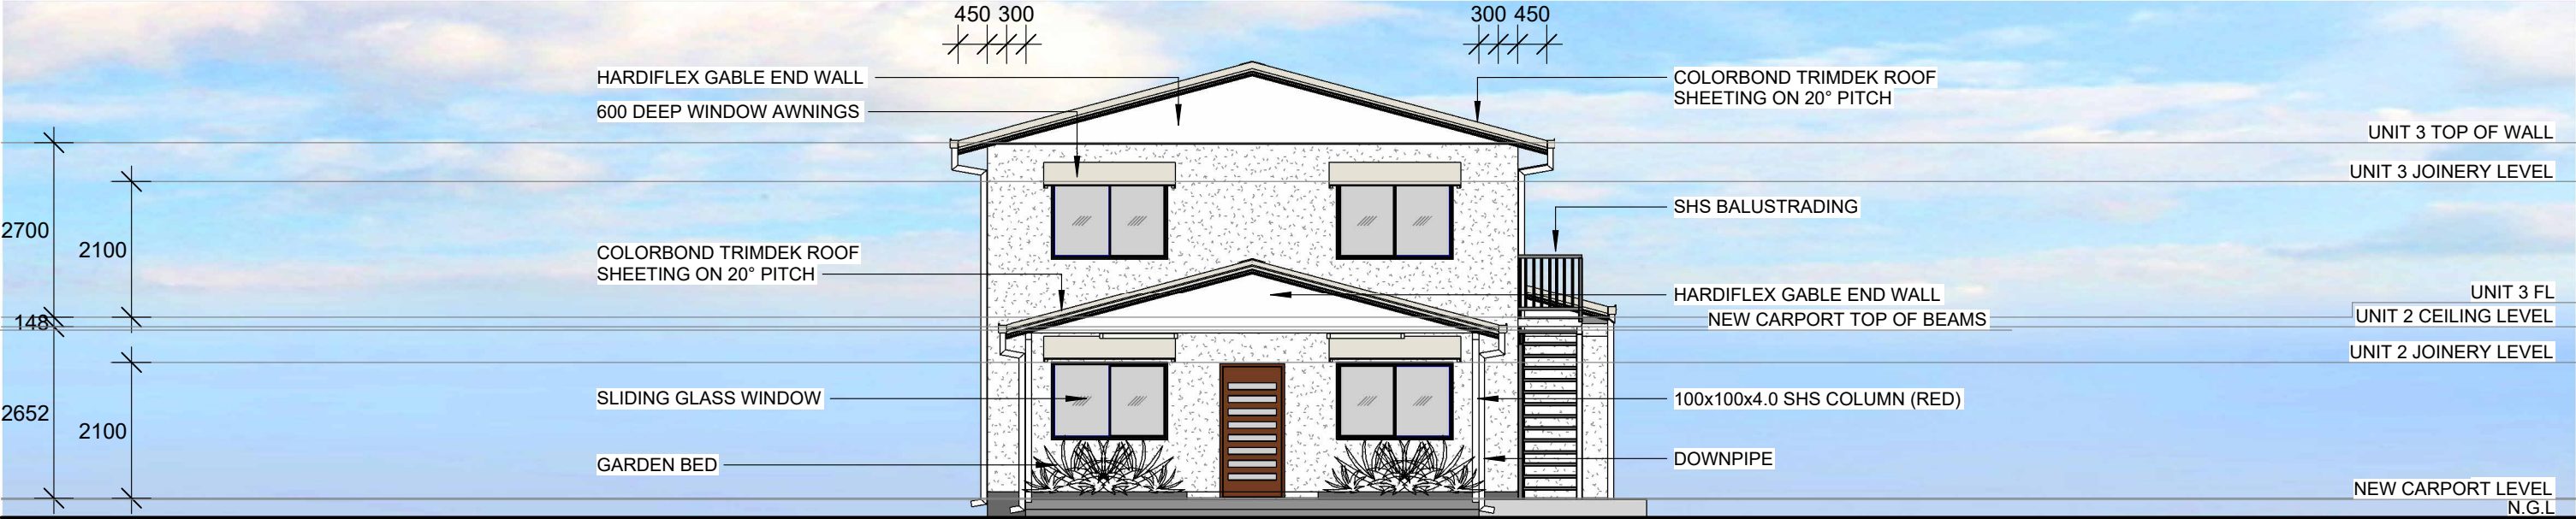

FRONT ELEVATION
SCALE: 1 : 100

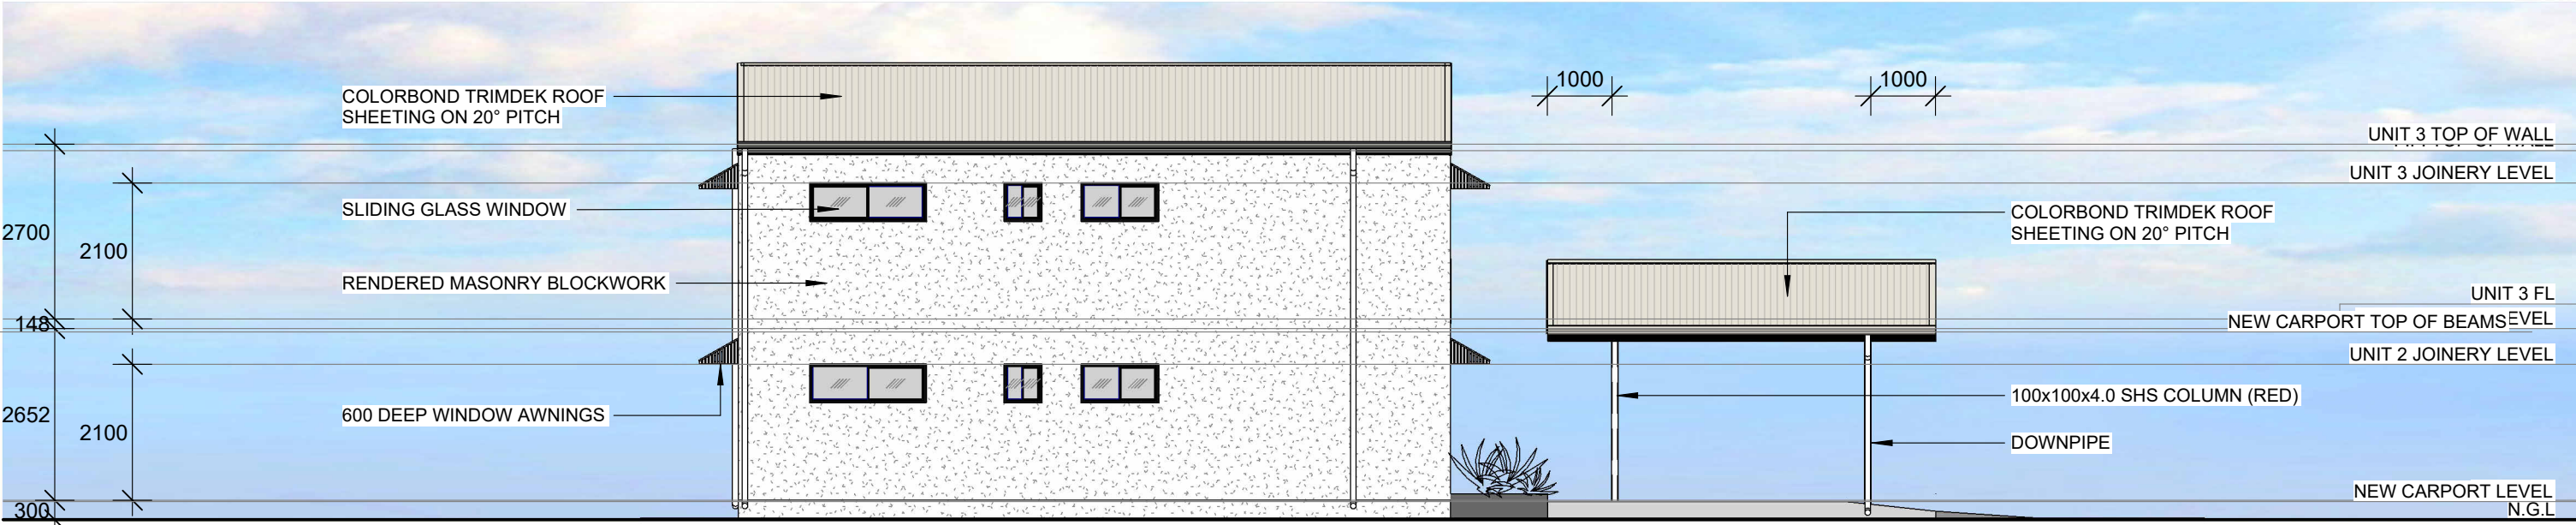

LEFT HAND SIDE ELEVATION
SCALE: 1 : 100

NOTE : -
DOWNPipes AS REQUIRED BY THE MANUFACTURER.
ROOF BRACING AS PER MANUFACTURER'S SPECIFICATION/LAYOUT PLANS.
CONSTRUCTION BRACING IS TO BE INSTALLED BEFORE THE PLACEMENT
OF ROOFING CONSTRUCTION IS COMMENCED.

**PRELIMINARY DRAWING
NOT FOR CONSTRUCTION**

 NTH QLD CONSTRUCTION CONSULTING P. L. P.O Box 21 AITKENVALE Q 4814 UNIT 1, 9 CIVIL RD, GARBUTT Q 4814 PH 4728 2339 - FAX 4728 2966 MOBILE PH 0429 001 726 EMAIL - bswitzer@nqcc.biz ABN & GST - 16 111 343 161	 building designers association of queensland inc.	COPYRIGHT © COPYRIGHT LAWS PROHIBIT THE USE OF THIS DESIGN IN ANY FORM WITHOUT WRITTEN CONSENT FROM NTH QLD CONSTRUCTION CONSULTING PTY LTD	AMENDMENTS			VERIFY ALL DIMENSIONS ON SITE BEFORE COMMENCING ANY BUILDING WORKS. LICENSED UNDER THE QLD BUILDING SERVICES AUTHORITY (QBSA Act 1991) BUILDING DESIGN DRAFTING RESIDENTIAL DESIGN DRAFTING CONTRACTOR LICENCE NUMBER - 1117428	CLIENT - ORANGE HEALTH CARE	
			DATE	REVISION	DESCRIPTION		PROJECT - EXTENSION TO RESIDENCE	
			18.02.26	A	FOR CLIENT DISCUSSION		LOCATION - 3 GELLING CRESCENT, DOUGLAS QLD 4814	
			24.03.26	B	DESIGN CHANGES FOR PLANNING		PROJECT NO. - 26-8309-OHC REVISION D	
			07.07.26	C	CONSTRUCTION ISSUE		DATE - FEBRUARY 2026	
15.07.26	D	SITE LAYOUT DETAILS ADDED AS PER COUNCIL REQUEST	DRAWN - GM		SCALE - AS SHOWN			
			CHECKED BY - B. J. SWITZER		SHEET NO. - 17 - A3			




REAR ELEVATION
SCALE: 1 : 100



RIGHT HAND SIDE ELEVATION
SCALE: 1 : 100

NOTE :-
DOWNPIPES AS REQUIRED BY THE MANUFACTURER.
ROOF BRACING AS PER MANUFACTURER'S SPECIFICATION/LAYOUT PLANS.
CONSTRUCTION BRACING IS TO BE INSTALLED BEFORE THE PLACEMENT
OF ROOFING CONSTRUCTION IS COMMENCED.

**PRELIMINARY DRAWING
NOT FOR CONSTRUCTION**

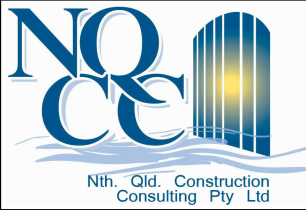

NTH QLD CONSTRUCTION CONSULTING P. L.
P.O Box 21 AITKENVALE Q 4814
UNIT 1, 9 CIVIL RD, GARbutt Q 4814
PH 4728 2339 - FAX 4728 2966
MOBILE PH 0429 001 726
EMAIL - bswitzer@nqcc.biz
ABN & GST - 16 111 343 161



COPYRIGHT ©
COPYRIGHT LAWS PROHIBIT
THE USE OF THIS DESIGN IN
ANY FORM WITHOUT
WRITTEN CONSENT FROM
NTH QLD CONSTRUCTION
CONSULTING PTY LTD

AMENDMENTS			DESCRIPTION
DATE	REVISION		
18.02.26	A		FOR CLIENT DISCUSSION
24.03.26	B		DESIGN CHANGES FOR PLANNING
07.07.26	C		CONSTRUCTION ISSUE
15.07.26	D		SITE LAYOUT DETAILS ADDED AS PER COUNCIL REQUEST

VERIFY ALL DIMENSIONS ON
SITE BEFORE COMMENCING
ANY BUILDING WORKS.

LICENSED UNDER THE QLD
BUILDING SERVICES AUTHORITY
(QBSA Act 1991)
BUILDING DESIGN DRAFTING
RESIDENTIAL DESIGN DRAFTING
CONTRACTOR LICENCE
NUMBER - 1117428

CLIENT - ORANGE HEALTH CARE	
PROJECT - EXTENSION TO RESIDENCE	
LOCATION - 3 GELLING CRESCENT, DOUGLAS QLD 4814	
PROJECT NO. - 26-8309-OHC	REVISION D
DATE - FEBRUARY 2026	
DRAWN - GM	SCALE - AS SHOWN
CHECKED BY - B. J. SWITZER	SHEET NO. - 18 - A3